


\\WESERVER1\Share\0355_002_00-HIGH PLAINS BANK - Keenesburg\Draw\CD\0355-001-02-WEC-SPR.dwg, PH1-PHOTO, 7/6/2021 2:41:51 PM, DWG To PDF.pc3

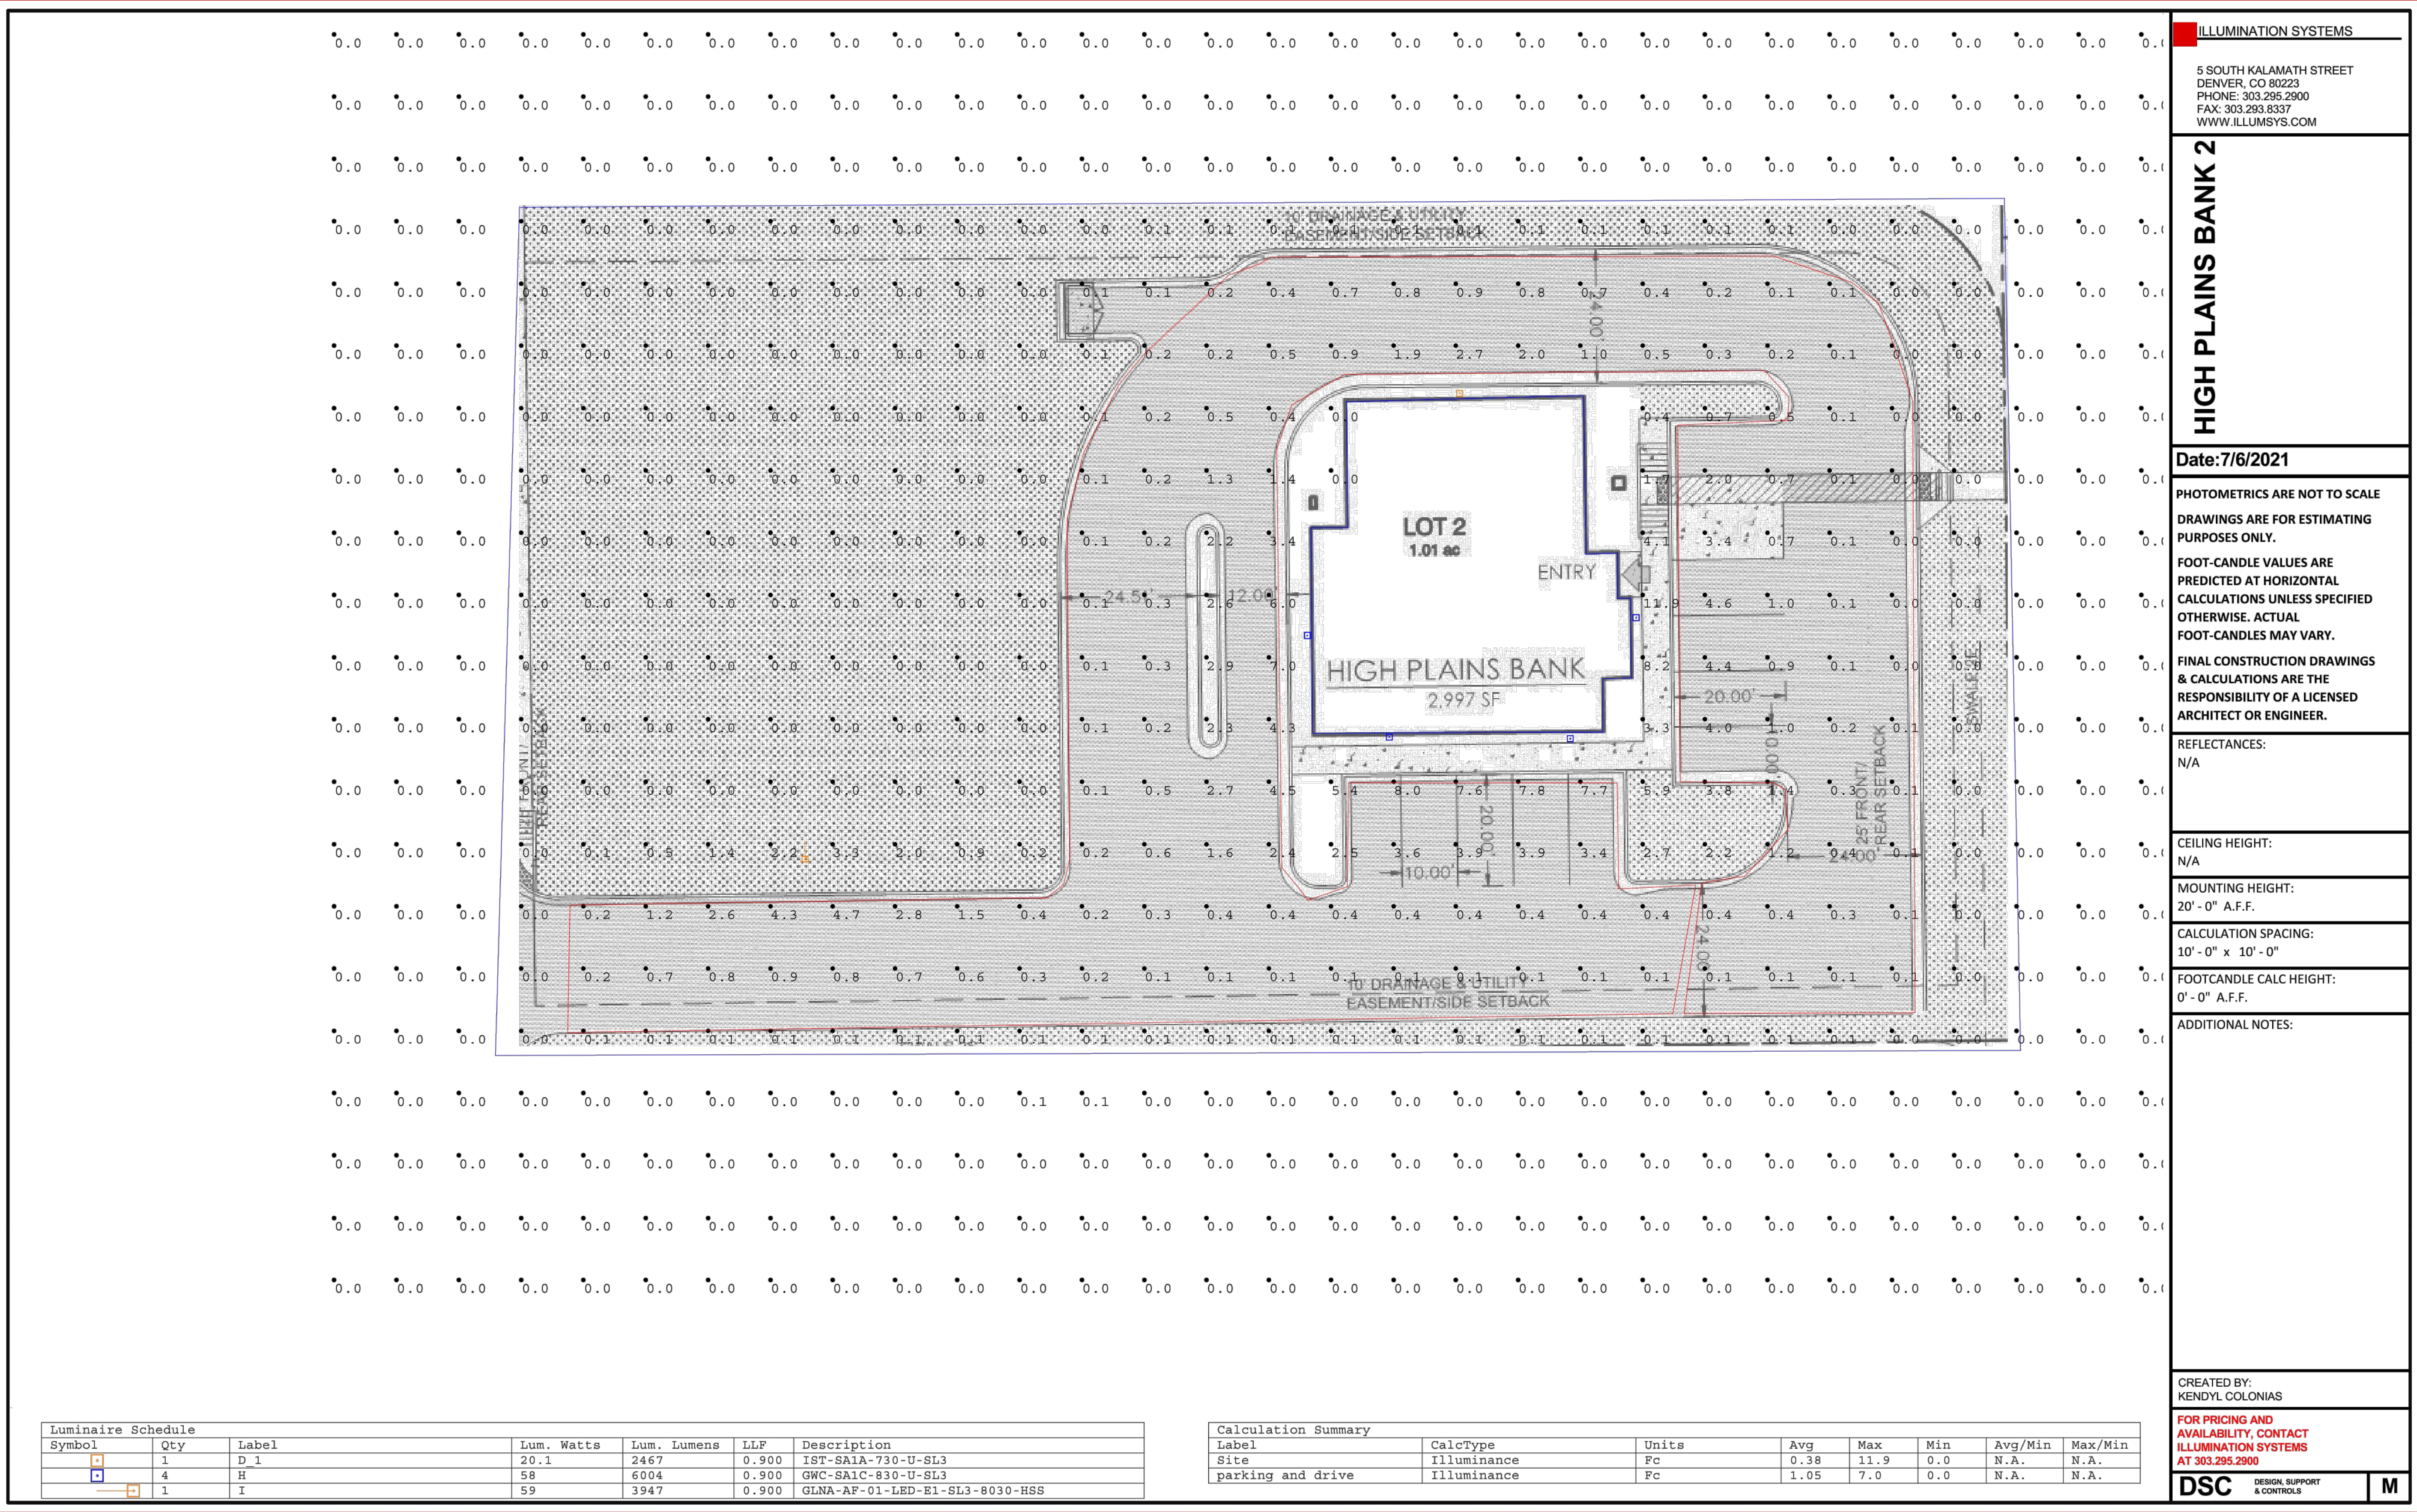

Luminaire Schedule									
Symbol	Qty	Label	Lum. Watts	Lum. Lumens	LLF	Description			
	1	D-1	20.1	2467	0.900	IST-SA1A-730-U-SL3			
	4	H	58	6004	0.900	GWC-SA1C-830-U-SL3			
	1	I	59	3947	0.900	GLNA-AF-01-LED-E1-SL3-8030-HSS			

Calculation Summary											
Label	CalcType	Units	Avg	Max	Min	Avg/Min	Max/Min				
Site	Illuminance	Fc	0.38	11.9	0.0	N.A.	N.A.				
parking and drive	Illuminance	Fc	1.05	7.0	0.0	N.A.	N.A.				

ILLUMINATION SYSTEMS

5 SOUTH KALAMATH STREET
DENVER, CO 80223
PHONE: 303.295.2900
FAX: 303.293.8337
WWW.ILLUMSYS.COM

HIGH PLAINS BANK 2

Date: 7/6/2021

PHOTOMETRICS ARE NOT TO SCALE
DRAWINGS ARE FOR ESTIMATING
PURPOSES ONLY.
FOOT-CANDLE VALUES ARE
PREDICTED AT HORIZONTAL
CALCULATIONS UNLESS SPECIFIED
OTHERWISE. ACTUAL
FOOT-CANDLES MAY VARY.
FINAL CONSTRUCTION DRAWINGS
& CALCULATIONS ARE THE
RESPONSIBILITY OF A LICENSED
ARCHITECT OR ENGINEER.

REFLECTANCES:
N/A

CEILING HEIGHT:
N/A

MOUNTING HEIGHT:
20'-0" A.F.F.

CALCULATION SPACING:
10'-0" x 10'-0"

FOOTCANDLE CALC HEIGHT:
0'-0" A.F.F.

ADDITIONAL NOTES:

CREATED BY:
KENDYL COLONIAS

FOR PRICING AND
AVAILABILITY, CONTACT
ILLUMINATION SYSTEMS
AT 303.295.2900

DSCDESIGN, SUPPORT
& CONTROLS

M

127 S. DENVER AVE
FT. LUTON, CO 80621
www.westernci.com
email@westernci.com
(720) 685-9951
FAX (720) 294-1330

Western Engineering Consultants, Inc. LLC

PHOTOMETRIC PLANS
MARKET STREET BUSINESS
PARK SUBDIVISION - LOT 2
TOWN OF KEENESBURG, WELD COUNTY, COLORADO

DigiSafely.
CALL UNCC
THREE WORKING DAYS
BEFORE YOU DIG
811
www.uncc.org
UTILITY NOTIFICATION
CENTER OF COLORADO

ONLY VALID FOR CONSTRUCTION
IF SEAL & ORIGINAL SIGNATURE
ARE ON EACH SHEET

INITIAL PLAN
RELEASE: 06/25/21
DESIGNED BY: CFC
DRAWN BY: CFC
CHECKED BY: CFC

PROJECT NO.
01-0355.001.02
DOC CON #
00PH1-PHOTO
SHEET
PH1 OF 28

